

NOTES

- This drawing is the property of AV Integration Distribution (India) Private Limited, Reproduction/Duplication of this drawing in part or whole is not permitted.
- All dimension are in millimeters unless otherwise indicate.
- Do not scale off this drawing.
- This drawings to be read in conjunction with all relevant architectural, civil/structural, and services engineer's drawing and specifications.
- Any discrepancies to be reported immediately to the architect.
- For Telephone/Data requirements, see drawings by others.
- Please maintain one feet space between the AV cables and Power cables.

REVISION & ISSUE

| REVNO | DATE | ISSUED TO |
|-------|------------|-----------|
| 00 | 16.01.2023 | ZEBRA |
| 01 | 08.02.2023 | ZEBRA |
| | | |
| | | |
AV SHOP DRAWINGS FOR
ZEBRA BAGMANE SOLARIUM CITY @ BANGALORE.

CLIENT

ZEBRA TECHNOLOGIES

BAGMANE SOLARIUMCITY, BANGALORE

SERVICE CONSULTANT

SPACE MATRIX

Space Matrix Design Consultants Pvt. Ltd.
#27/6 Sankey Road, Bangalore - 560 052
FAX: Phone:080 4049 4000 080 4049 4299

PROJECT MANAGEMENT

JLL

UB CITY, 24, LEVEL 3, CONCORDE, VITTAL MALLYA RD, BENGALURU, KARNATAKA 560001

AV SYSTEM DESIGN&CONSULTANT

3CDN

1ST FLOOR, # 1776, 15TH MAIN, 5TH BLOCK, HBR LAYOUT, KALYAN NAGAR, BANGALORE -560043

AV SYSTEM INTEGRATED BY

AVI


AV Integration Distribution (India) Pvt.Ltd., #300, Samrudhi, 1st Block RT Nagar Bangalore-560032, India
Tel : 91-80-41267472
Fax : 91-80-41267473
email : mail@avidindia.in
URL : www.avidindia.in

DRAWING TITLE

GROUND FLOOR
20 PAX BOARD ROOM
AUDIO SCHEMATICS

| | | | |
|------------------|--------------------------|-------|------------|
| DRAWN BY | SHEIK | SCALE | NTS |
| CHECKED BY | VETRI | DATE | 08.02.2023 |
| APPROVED BY | RAJESH | SHEET | A3/01 |
| PROJECT NUMBER : | PC-0123-00888 | REV | |
| DRAWING NUMBER : | AVI-D-ZEB-GF-20PBR-AS-01 | REV | 01 |

20 PAX BOARD ROOM AUDIO SCHEMATICS

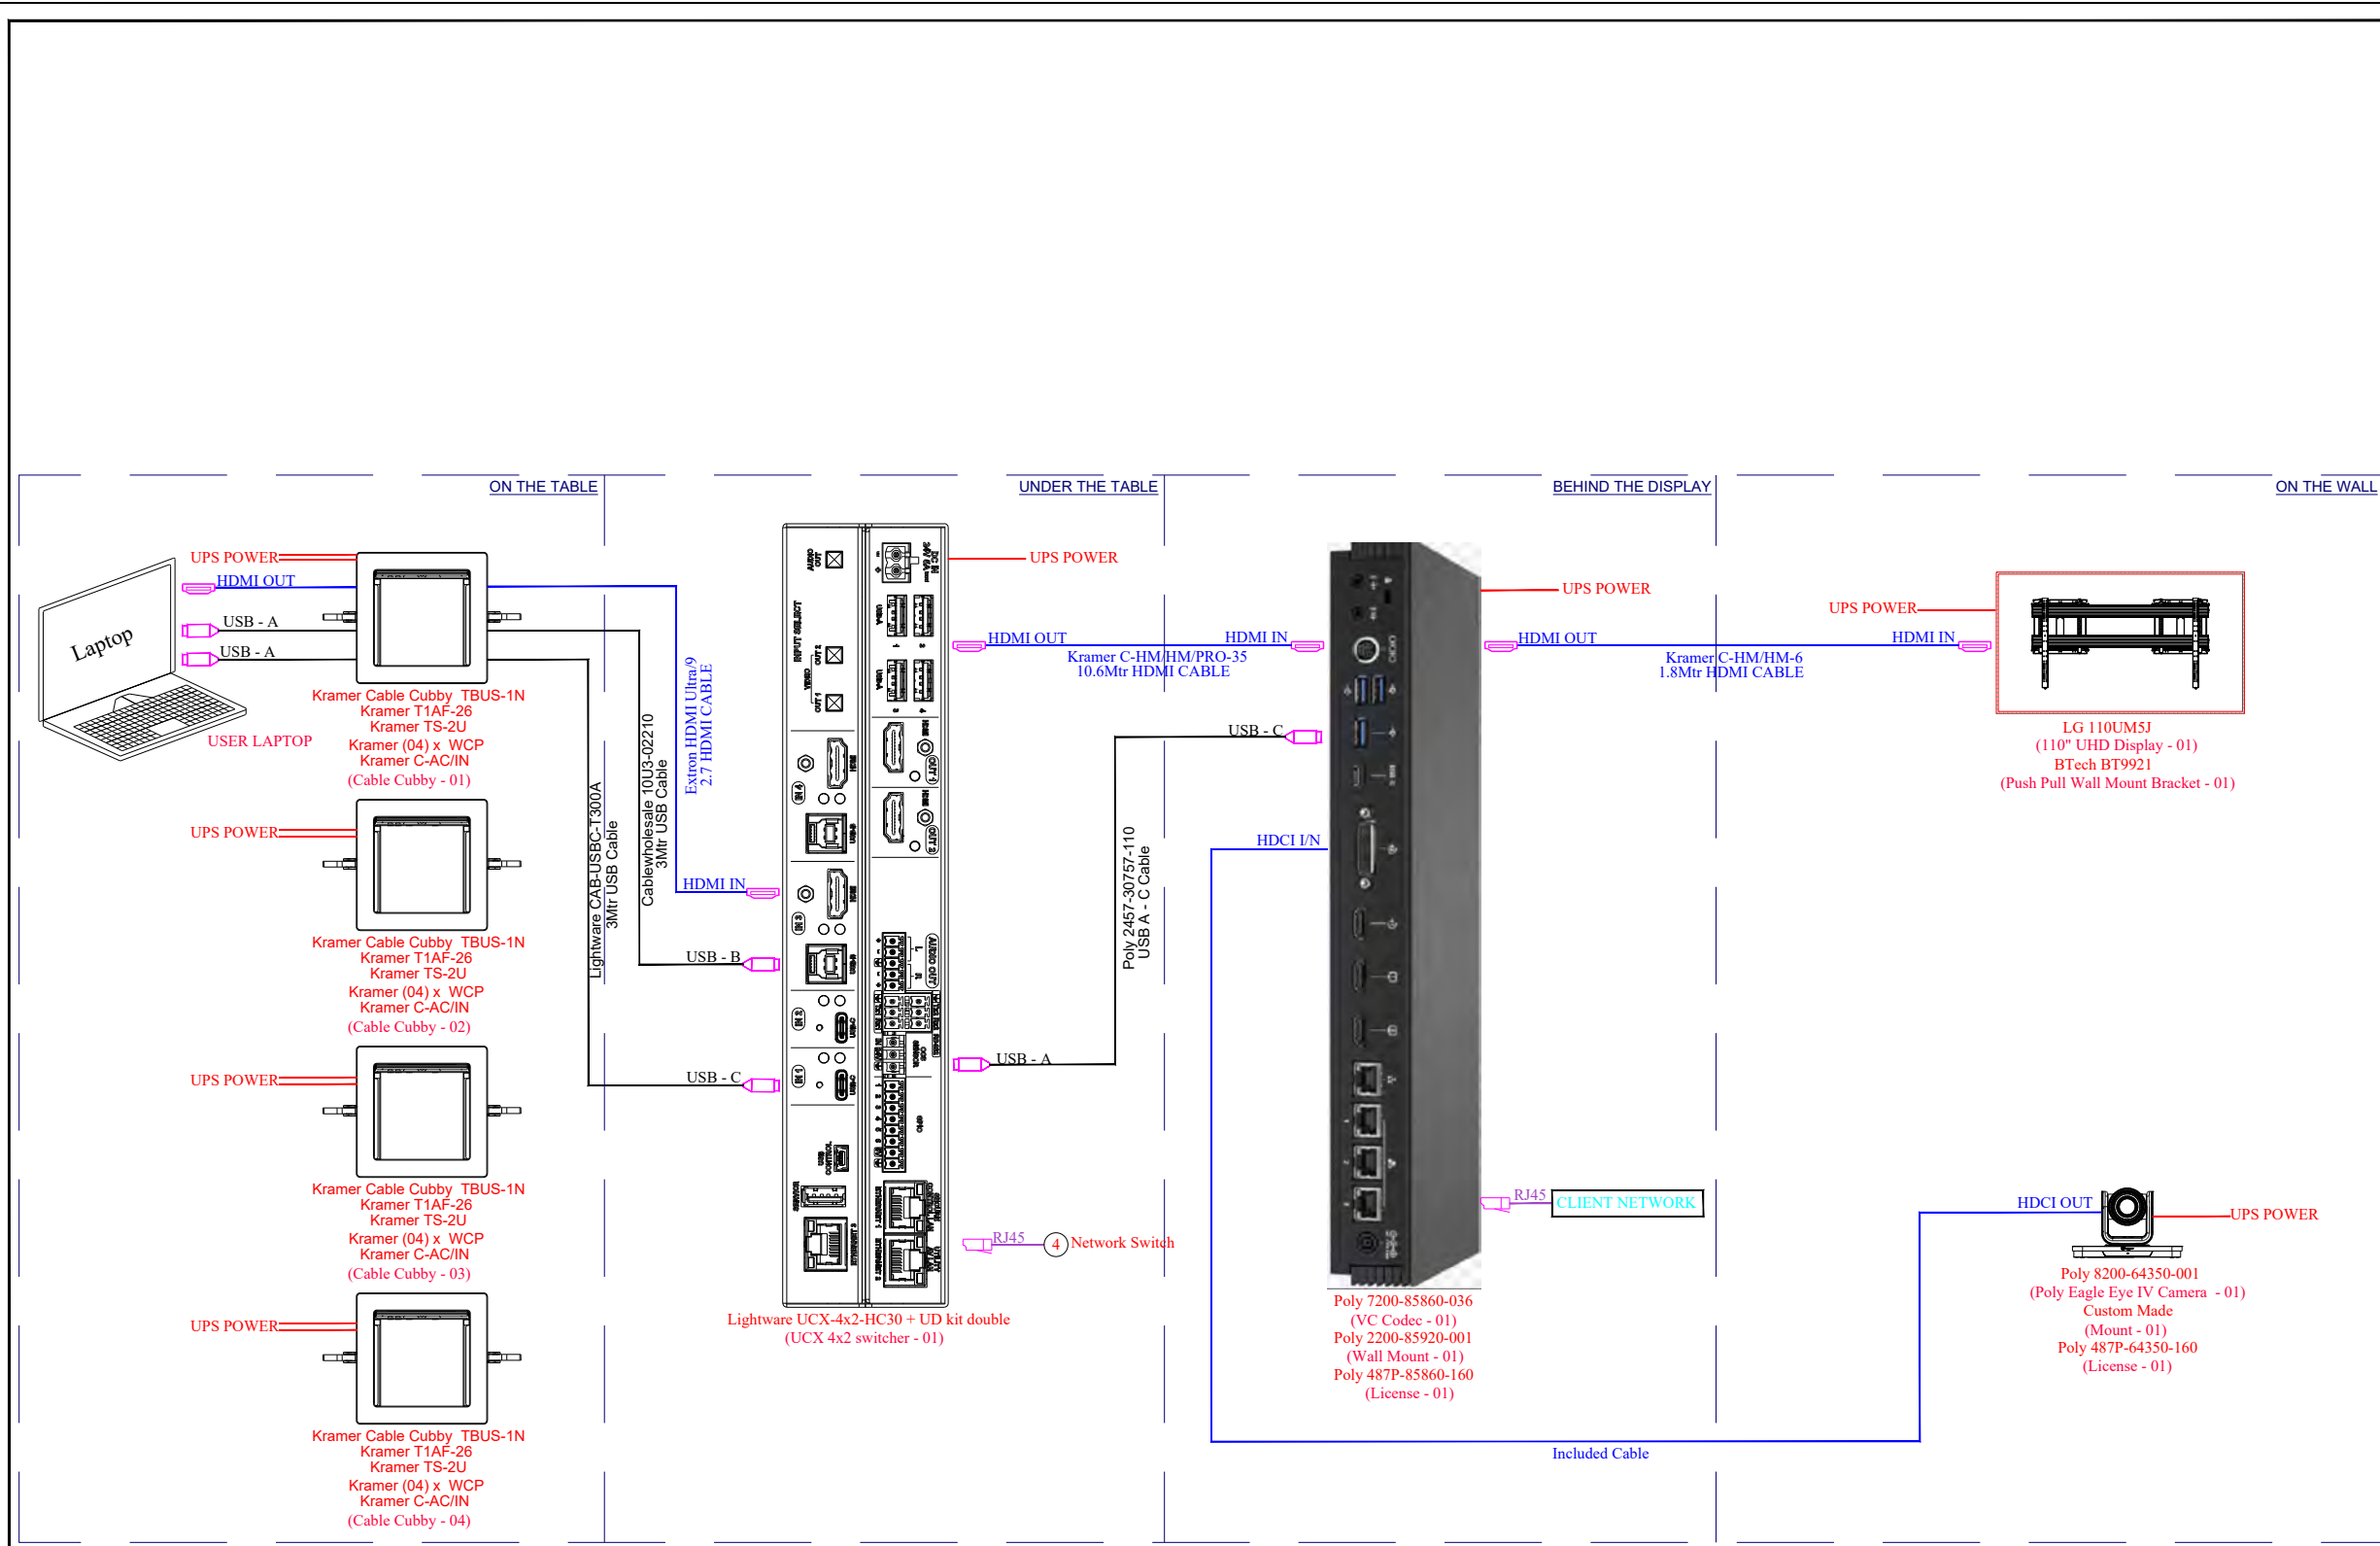

NOTES

1. This drawing is the property of AV Integration Distribution (India) Private Limited. Reproduction/Duplication of this drawing in part or whole is not permitted.
2. All dimension are in millimeters unless otherwise indicate.
3. Do not scale off this drawing.
4. This drawings to be read in conjunction with all relevant architectural, civil/structural, and services engineer's drawing and specifications.
5. Any discrepancies to be reported immediately to the architect.
6. For Telephone/Data requirements, see drawings by others.
7. Please maintain one feet space between the AV cables and Power cables.

REVISION & ISSUE

| REVNO | DATE | ISSUED TO |
|-------|------------|-----------|
| 00 | 16.01.2023 | ZEBRA |
| 01 | 08.02.2023 | ZEBRA |
| | | |
| | | |
| | | |
| | | |
| | | |
| | | |
| | | |
| | | |

AV SHOP DRAWINGS FOR

ZEBRA BAGMANE SOLARIUM CITY @ BANGALORE.

CLIENT



BAGMANE SOLARIUMCITY, BANGALORE

SERVICE CONSULTANT

SPACE MATRIX
Space Matrix Design Consultants Pvt. Ltd.
#27/6 Sankey Road, Bangalore - 560 052
FAX: Phone:080 4049 4000 080 4049 4299

PROJECT MANAGEMENT

JLL
UB CITY, 24, LEVEL 3, CONCORDE, VITTAL MALLYA RD, BENGALURU, KARNATAKA 560001

AV SYSTEM DESIGN&CONSULTANT

3CDN
1ST FLOOR, # 1776, 15TH MAIN, 5TH BLOCK, HBR LAYOUT, KALYAN NAGAR, BANGALORE -560043

AV SYSTEM INTEGRATED BY

AVI
AV Integration Distribution (India) Pvt.Ltd., #300, Samrudhi, 1st Block RT Nagar Bangalore-560032, India
Tel : 91-80-41267472
Fax : 91-80-41267473
email : mail@avidindia.in
URL : www.avidindia.in

DRAWING TITLE


GROUND FLOOR
20 PAX BOARD ROOM
VIDEO SCHEMATICS

| | | | |
|-------------|--------|-------|------------|
| DRAWN BY | SHEIK | SCALE | NTS |
| CHECKED BY | VETRI | DATE | 08.02.2023 |
| APPROVED BY | RAJESH | SHEET | A3/01 |

PROJECT NUMBER : PC-0123-08888
DRAWING NUMBER : AVID-ZEB-GF-20PBR-VS-02

**20 PAX BOARD ROOM
VIDEO SCHEMATICS**

REV: 01

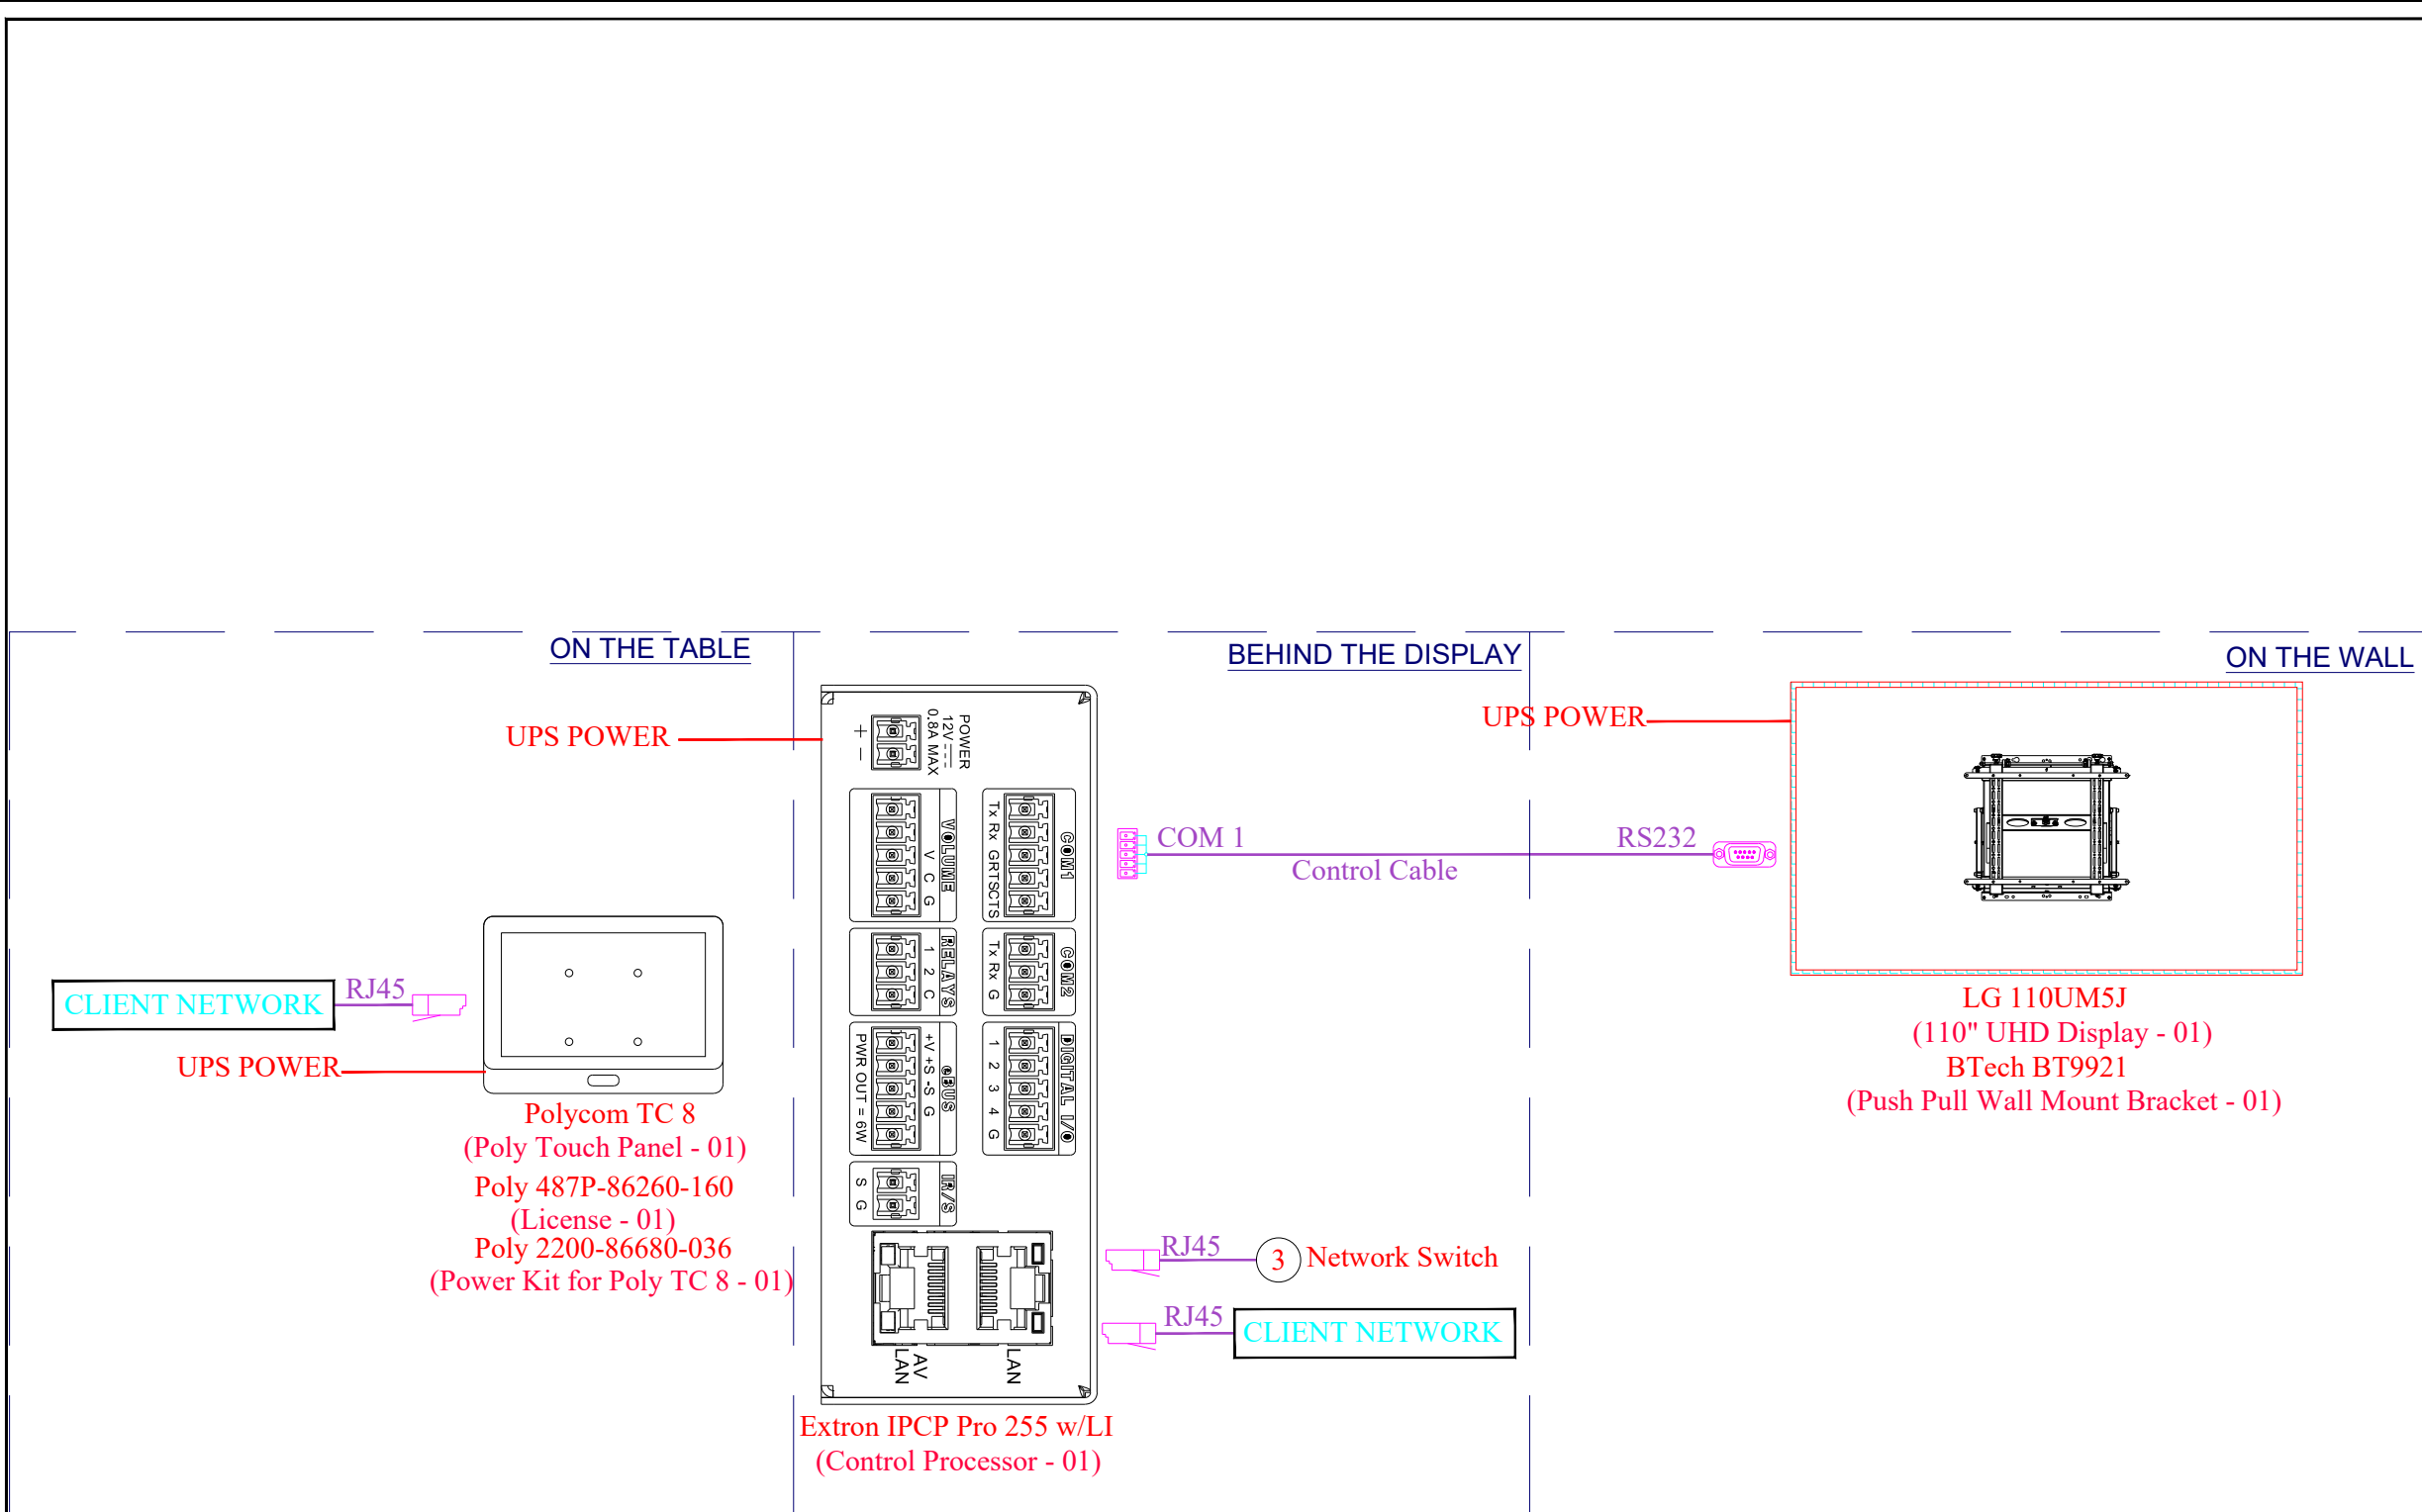

NOTES

1. This drawing is the property of AV Integration Distribution (India) Private Limited. Reproduction/Duplication of this drawing in part or whole is not permitted.
2. All dimension are in millimeters unless otherwise indicate.
3. Do not scale off this drawing.
4. This drawings to be read in conjunction with all relevant architectural, civil/structural, and services engineer's drawing and specifications.
5. Any discrepancies to be reported immediately to the architect.
6. For Telephone/Data requirements, see drawings by others.
7. Please maintain one feet space between the AV cables and Power cables.

REVISION & ISSUE

| REVNO | DATE | ISSUED TO |
|-------|------------|-----------|
| 00 | 16.01.2023 | ZEBRA |
| 01 | 08.02.2023 | ZEBRA |
| | | |
| | | |
| | | |
| | | |
| | | |
| | | |
| | | |

AV SHOP DRAWINGS FOR
ZEBRA BAGMANE SOLARIUM CITY @ BANGALORE.

CLIENT

BAGMANE SOLARIUMCITY, BANGALORE

SERVICE CONSULTANT

Space Matrix Design Consultants Pvt. Ltd.
 #27/6 Sankey Road, Bangalore - 560 052
 FAX: Phone:080 4049 4000 080 4049 4299

PROJECT MANAGEMENT

UB CITY, 24, LEVEL 3, CONCORDE, VITTAL MALLYA RD, BENGALURU, KARNATAKA 560001

AV SYSTEM DESIGN&CONSULTANT

1ST FLOOR, # 1776, 15TH MAIN, 5TH BLOCK, HBR LAYOUT, KALYAN NAGAR, BANGALORE -560043

AV SYSTEM INTEGRATED BY

AV Integration Distribution (India) Pvt.Ltd., #300, Samrudhi, 1st Block RT Nagar Bangalore-560032, India
 Tel : 91-80-41267472
 Fax : 91-80-41267473
 email : mail@avidindia.in
 URL : www.avidindia.in

DRAWING TITLE

GROUND FLOOR
 20 PAX BOARD ROOM
 CONTROL SCHEMATICS

| | | | |
|------------------|-------------------------|-------|------------|
| DRAWN BY | SHEIK | SCALE | NTS |
| CHECKED BY | VETRI | DATE | 08.02.2023 |
| APPROVED BY | RAJESH | SHEET | A3/01 |
| PROJECT NUMBER : | PC-0123-00888 | REV | |
| DRAWING NUMBER : | AVID-ZEB-GF-20PBR-CS-03 | REV | 01 |

20 PAX BOARD ROOM CONTROL SCHEMATICS